
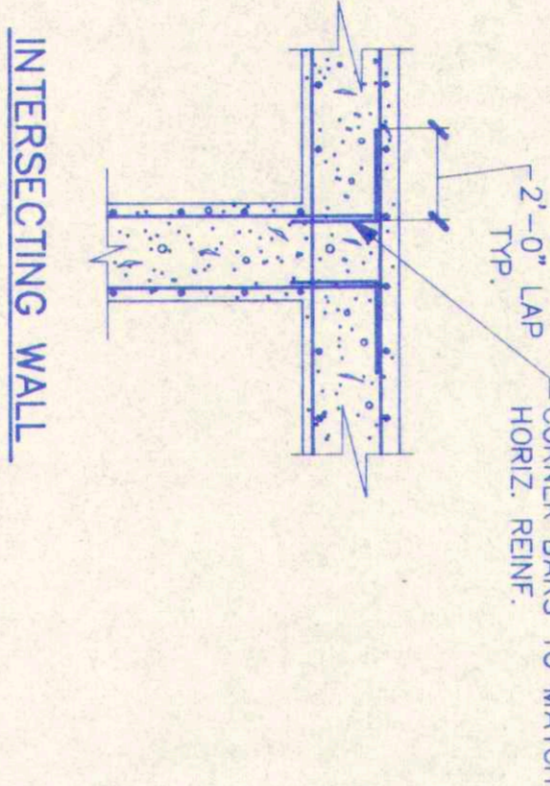



BOLLARD DETAIL
SCALE: 3/4" = 1'-0"

(1)
A202

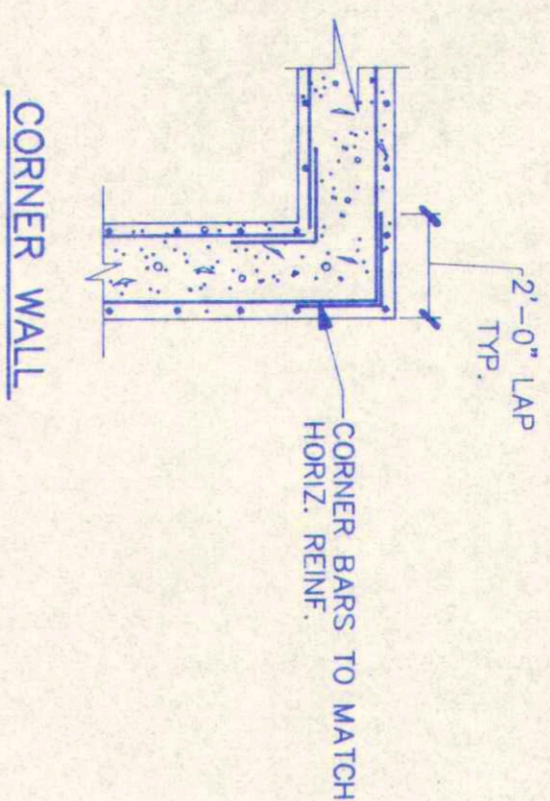


TYPICAL WALL REINFORCING (PLAN VIEW)

(2)
A202

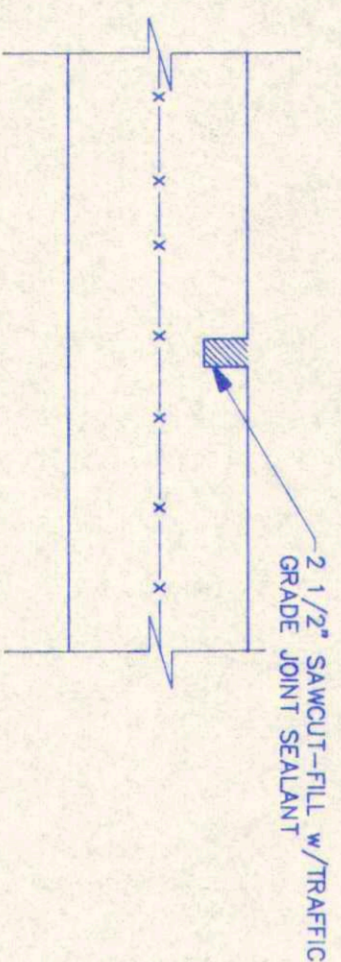

CONTROL JOINT DETAIL

(3)
A202

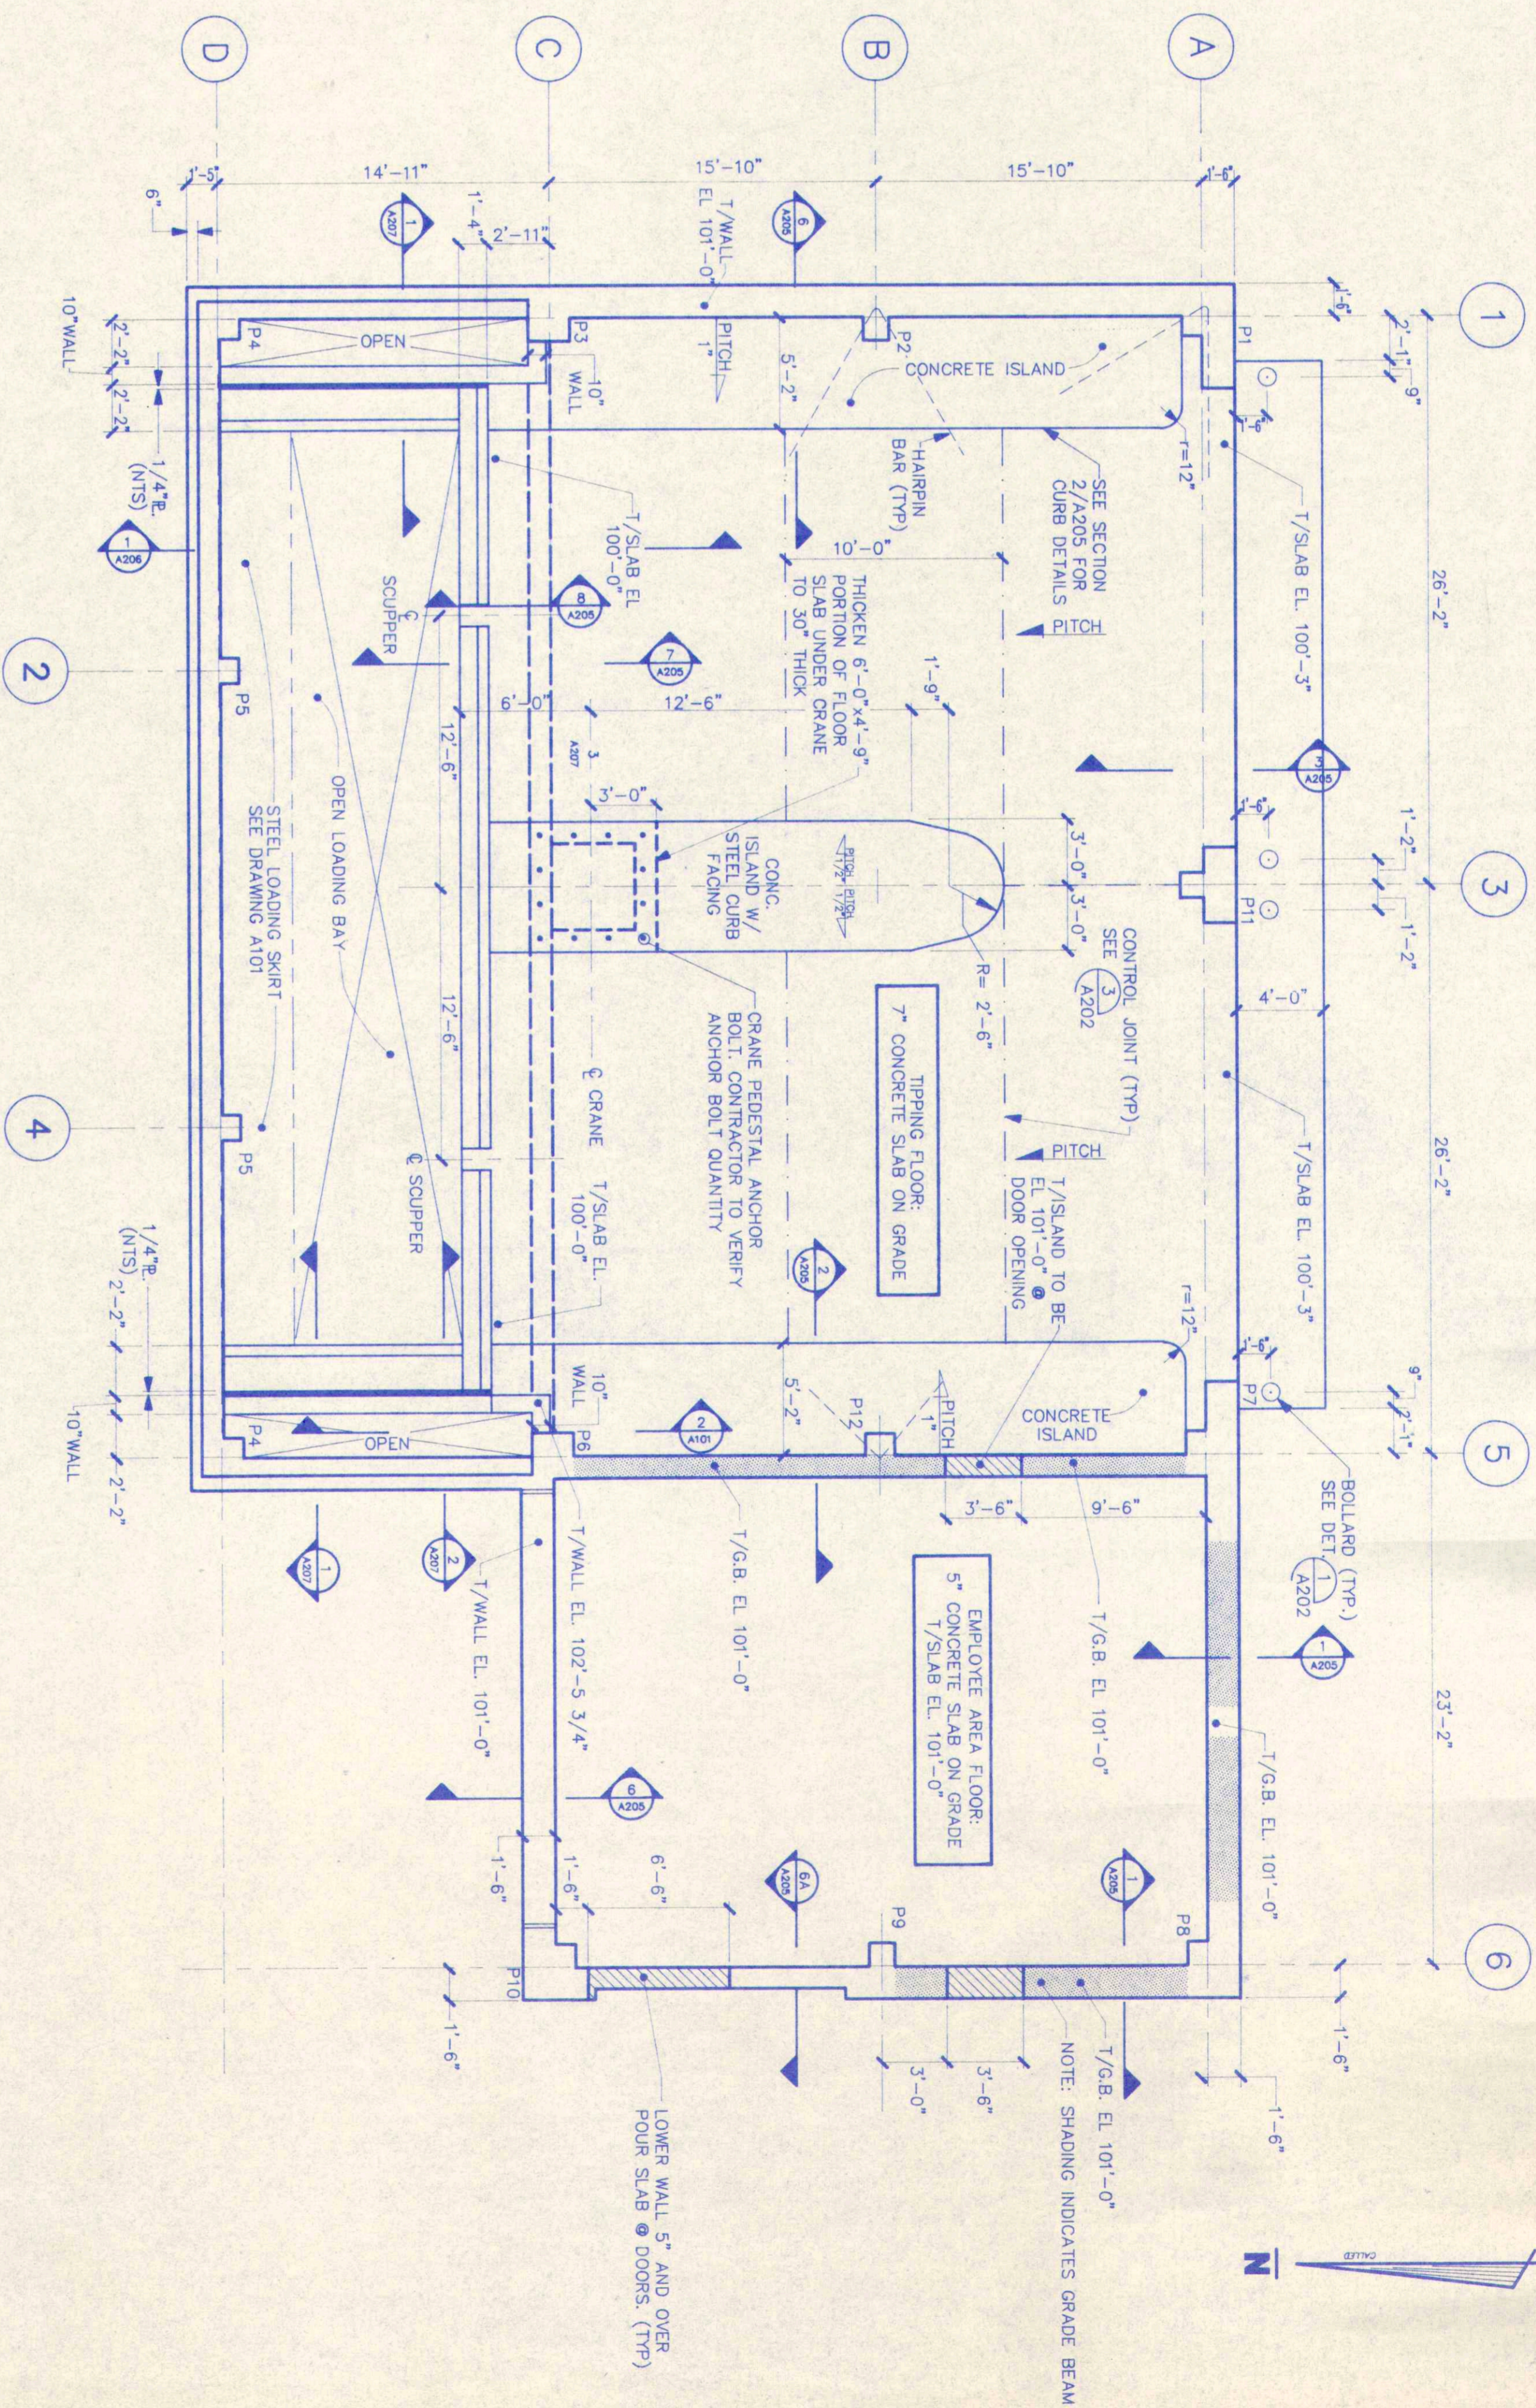

FOUNDATION PLAN @ TIPPING FLOOR LEVEL

SCALE: 3/16" = 1'-0"

RECORD DRAWINGS

These construction contract drawings have been modified by the ENGINEER to record significant changes during construction as reported by the contractor. The work shown on these drawings is the work actually constructed as designed by the ENGINEER. Record drawings do not apply to existing conditions prior to construction or subsequent work after construction was completed.
Dwn By: EKT Chd By: REK Date: 6-23-91

CAD FILE: W00TIPFRS.DWG

revisions	drawn by	app'd by	date
A) ISSUED FOR BIDD	R.A.M.	M.G.N.	9-21-88
B) ISSUED FOR BID	R.A.M.	P.F.K.	3-2-90



SMITH & MAHONEY, P.C.
CONSULTING ENGINEERS & SURVEYORS
79 NORTH PEARL STREET ALBANY, NEW YORK

Attention of this document except by a licensed Professional Engineer, is illegal.
signature _____

designed by: P.F.K.
drawn by: R.A.M.
checked by: P.F.K.
approved by: P.F.K.
scale: AS SHOWN
date: MARCH 2, 1990

MONTGOMERY COUNTY
SOLID WASTE TRANSFER STATION
CITY OF AMSTERDAM * MONTGOMERY COUNTY * NEW YORK
TRANSFER BUILDING - FOUNDATION PLAN @ TIPPING FLOOR LEVEL

sheet number
A202
REV. NO. 3 OF 41
DWG. NO. E-9-0333
B