


Jan 08, 2021 - 3:23pm
 F:\Project\F42 - VERIZON\F42.001.011 UNY NSB Macro 2016\Design\CADD\Aurriesville\Lease\Sheet Files\F42001011_LE-001.DWG



- NOTES:**
1. THE PLAN WAS DEVELOPED FROM AERIAL PHOTOGRAPHY AND TAX MAPS. EXISTING CONDITIONS ARE APPROXIMATE AND NOT THE RESULT OF A FORMAL INSTRUMENT SURVEY.
 2. NORTH ORIENTATION IS APPROXIMATE AND WAS ESTABLISHED FROM PHOTOGRAMMETRY.
 3. LESSOR SHALL GRANT THE NECESSARY LEASE PARCEL; INGRESS/EGRESS AND UTILITY CABLING EASEMENTS FOR THE PROPOSED LESSEE WIRELESS TELECOMMUNICATIONS FACILITY. THIS SITE LAYOUT LEASE PARCEL AND EASEMENT LOCATIONS MAY BE SUBJECT TO CHANGE BY MUTUAL AGREEMENT OF BOTH PARTIES (LESSEE & LESSOR) AS REQUIRED AS A RESULT OF THE COMPLETION OF A FIELD SURVEY AND/OR THE ZONING APPROVAL PROCESS.

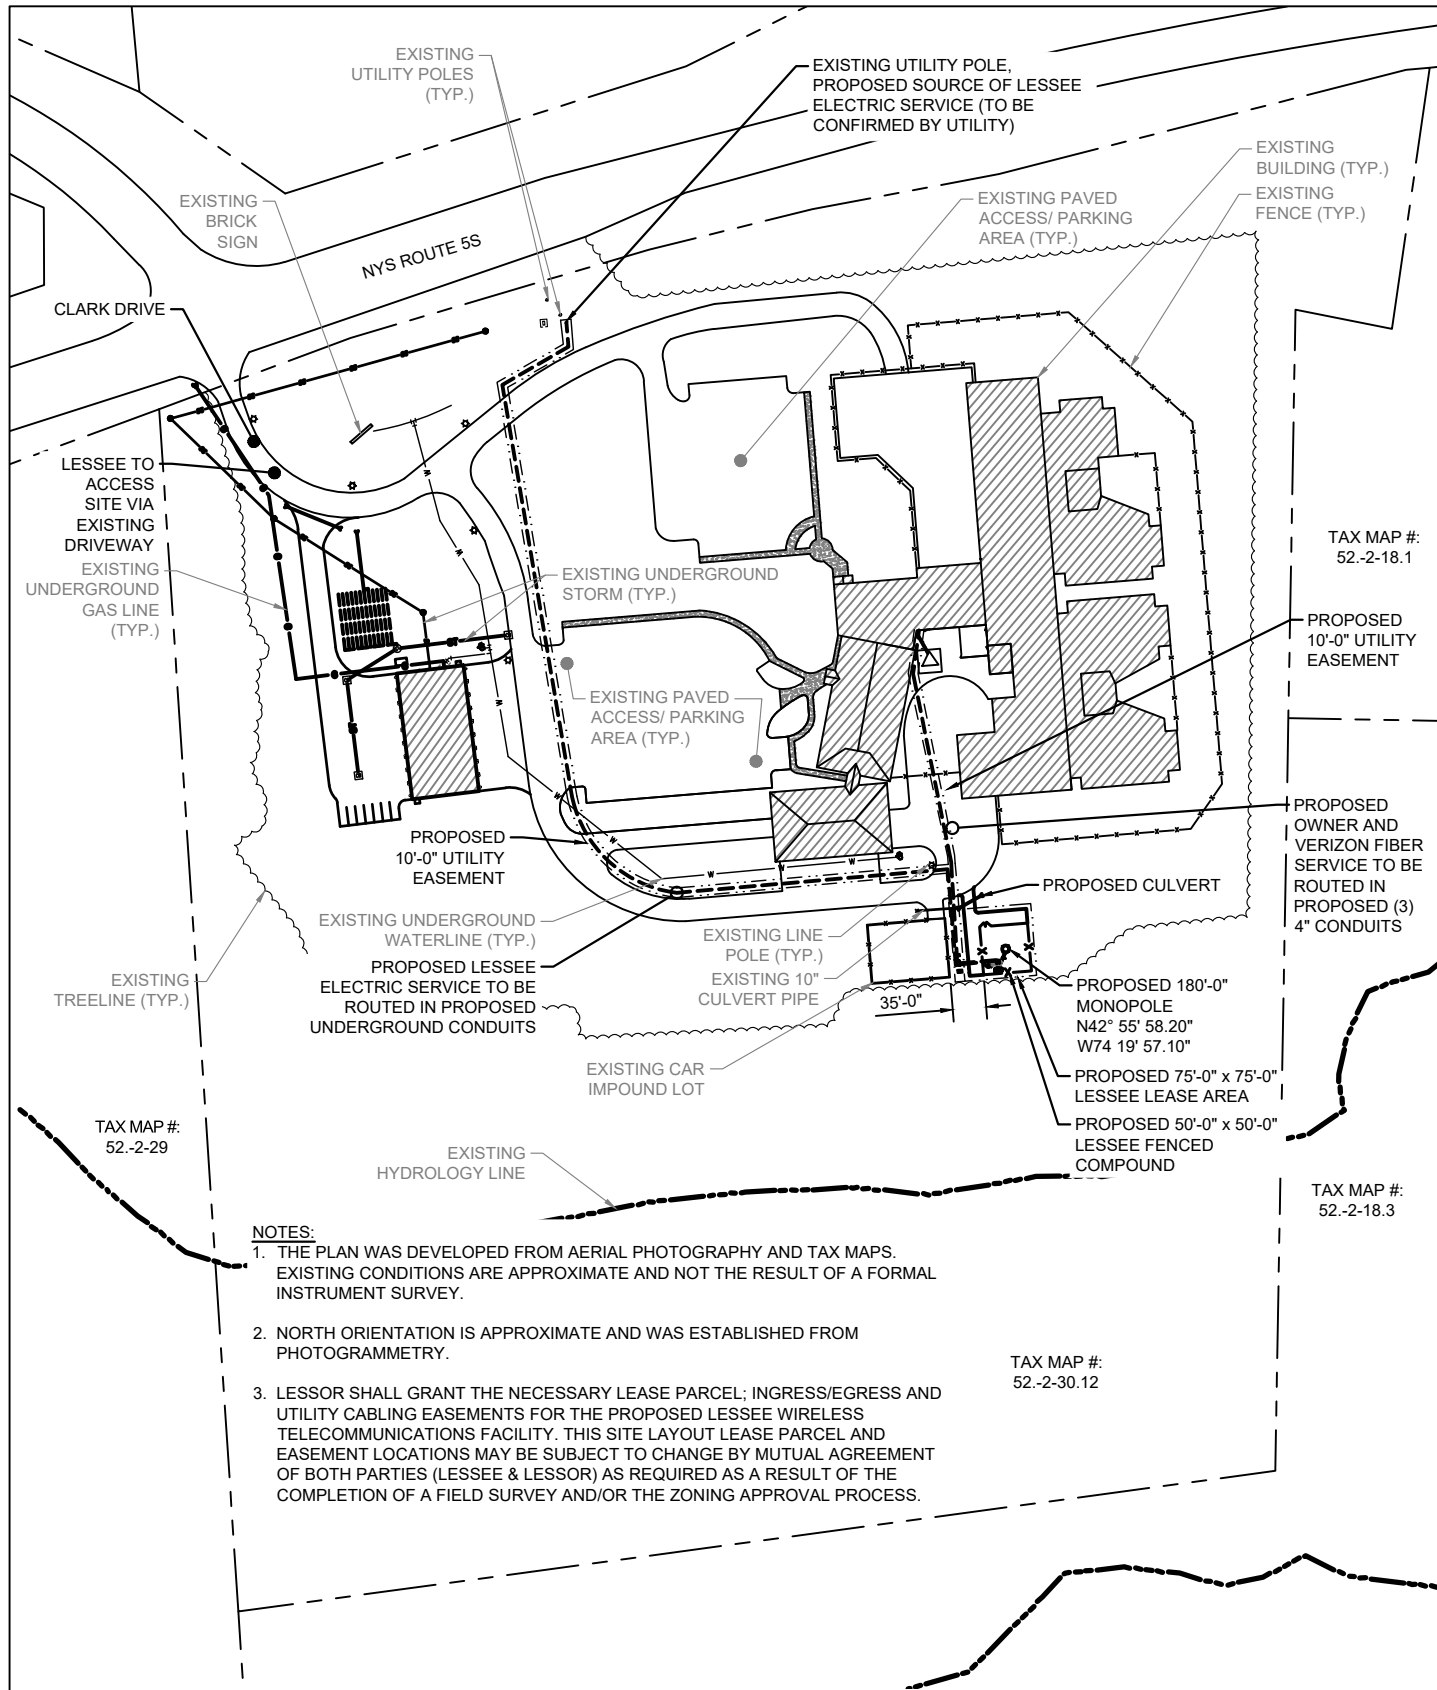


OVERALL SITE PLAN
 SCALE: 1" = 200'-0"



C&S Engineers, Inc.
 499 Col. Eileen Collins Blvd.
 Syracuse, New York 13212
 Phone: 315-455-2000
 Fax: 315-455-9667
 www.cscos.com


SITE NAME: AURIRESVILLE	
PROJECT NUMBER: 2014107930	
LOCATION CODE: 298618	
200 CLARK DRIVE FULTONVILLE, NY 12072	
ORIGINAL DATE: 12-9-20	REVISION DATE: 1-8-21



OVERALL SITE PLAN

DRAWING NUMBER	REV
LE-001	1

Jan 08, 2021 - 3:23pm
 F:\Project\F42 - VERIZON\F42.001.011 UNY NSB Macro 2016\Design\CADD\Aurivesville\Lease\Sheet Files\F42001011_C-101.DWG

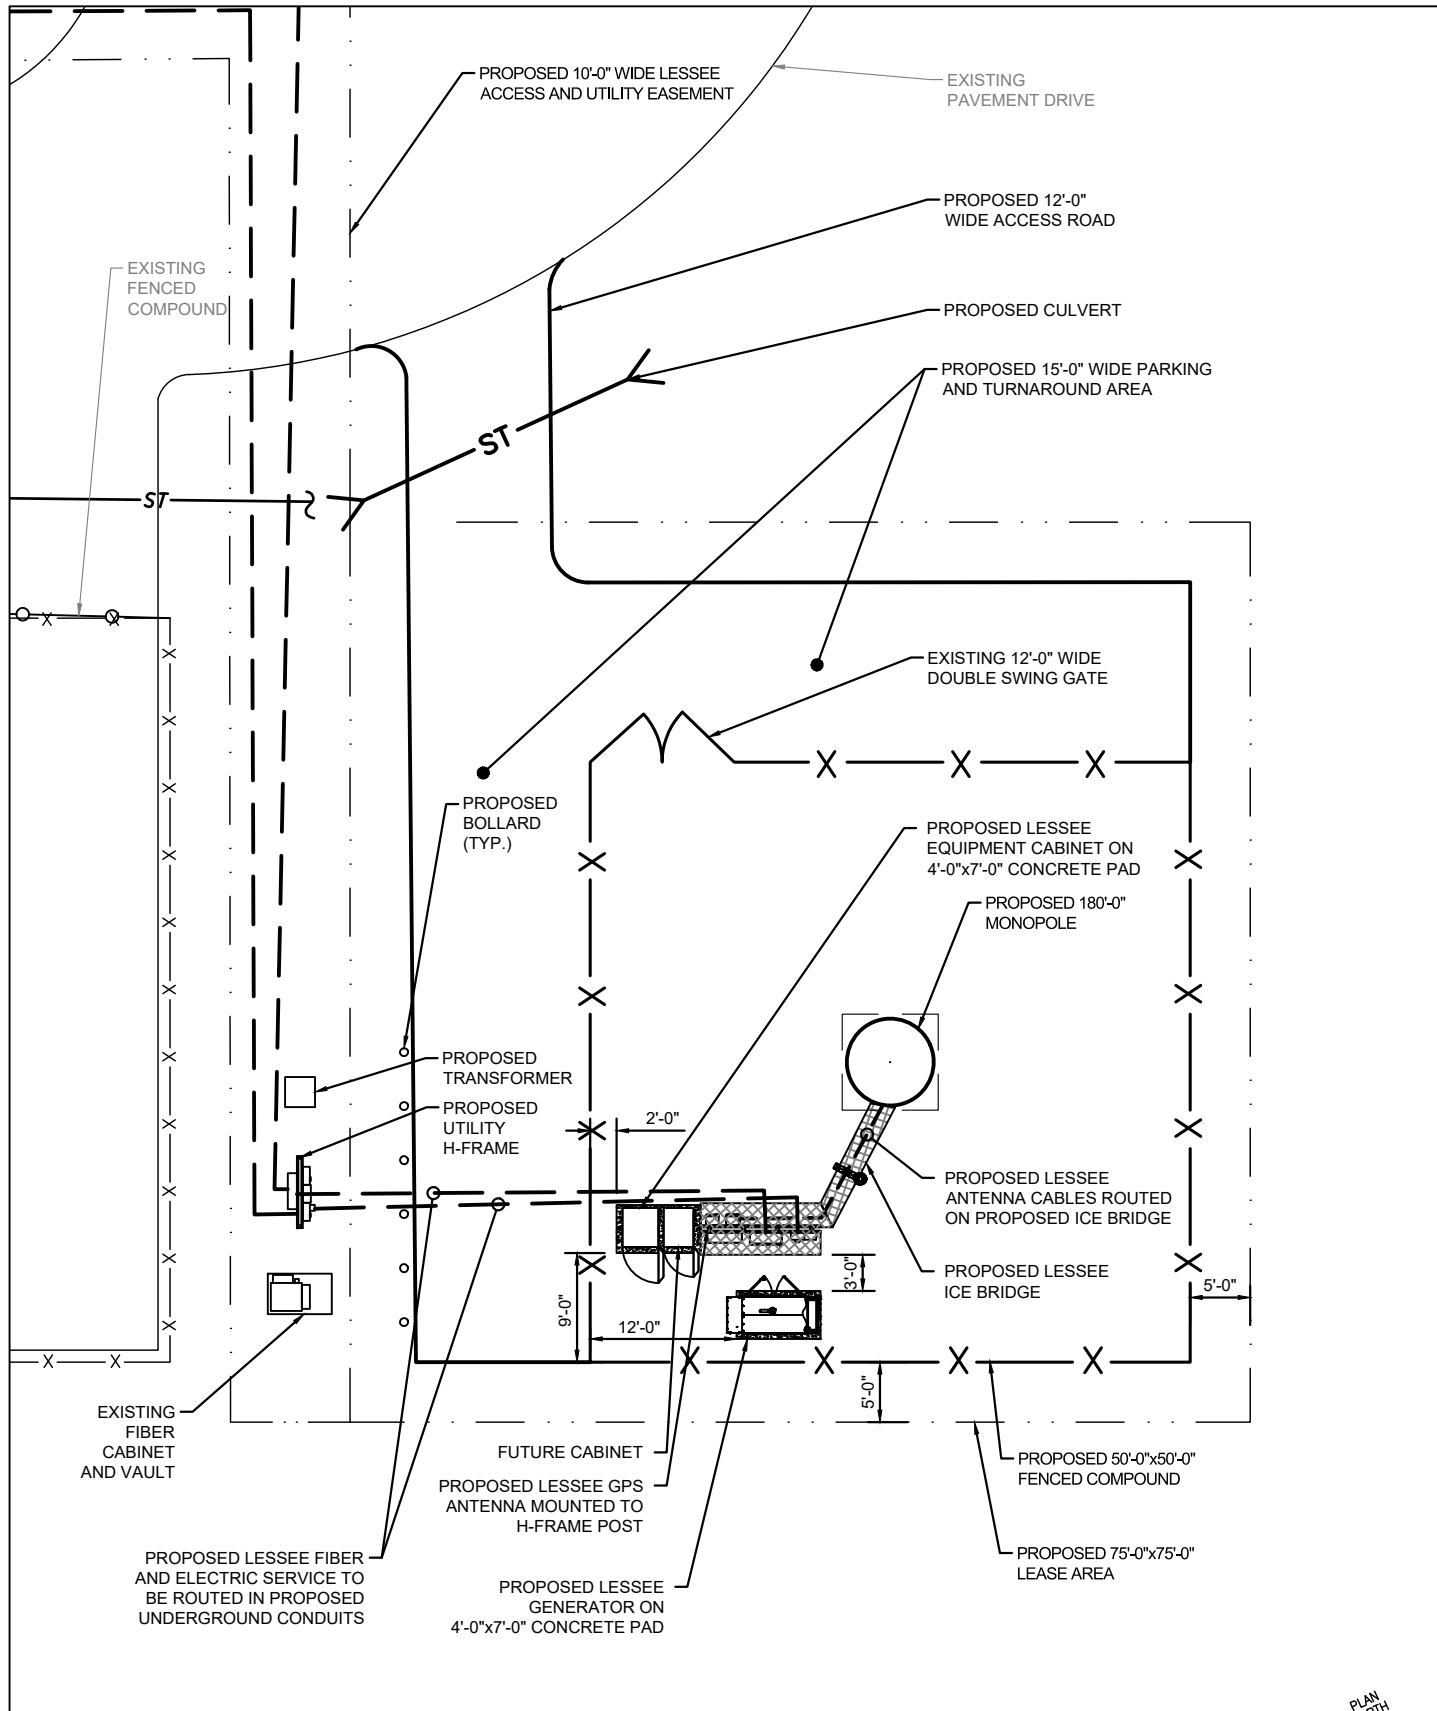

EQUIPMENT LAYOUT PLAN
 SCALE: 1" = 16'-0"



C&S Engineers, Inc.
 499 Col. Eileen Collins Blvd.
 Syracuse, New York 13212
 Phone: 315-455-2000
 Fax: 315-455-9667
 www.cscos.com


SITE NAME: AURIVESVILLE
PROJECT NUMBER: 2014107930
LOCATION CODE: 298618



200 CLARK DRIVE FULTONVILLE, NY 12072	
ORIGINAL DATE: 12-9-20	REVISION DATE: 1-8-21

EQUIPMENT LAYOUT PLAN	
DRAWING NUMBER: C-101	REV: 1

Jan 08, 2021 - 3:24pm
 F:\Project\F42 - VERIZON\F42.001.011 UNY NSB Macro 2016\Design\CADD\Auriersville\Lease\Sheet Files\F42001011_C-201.DWG

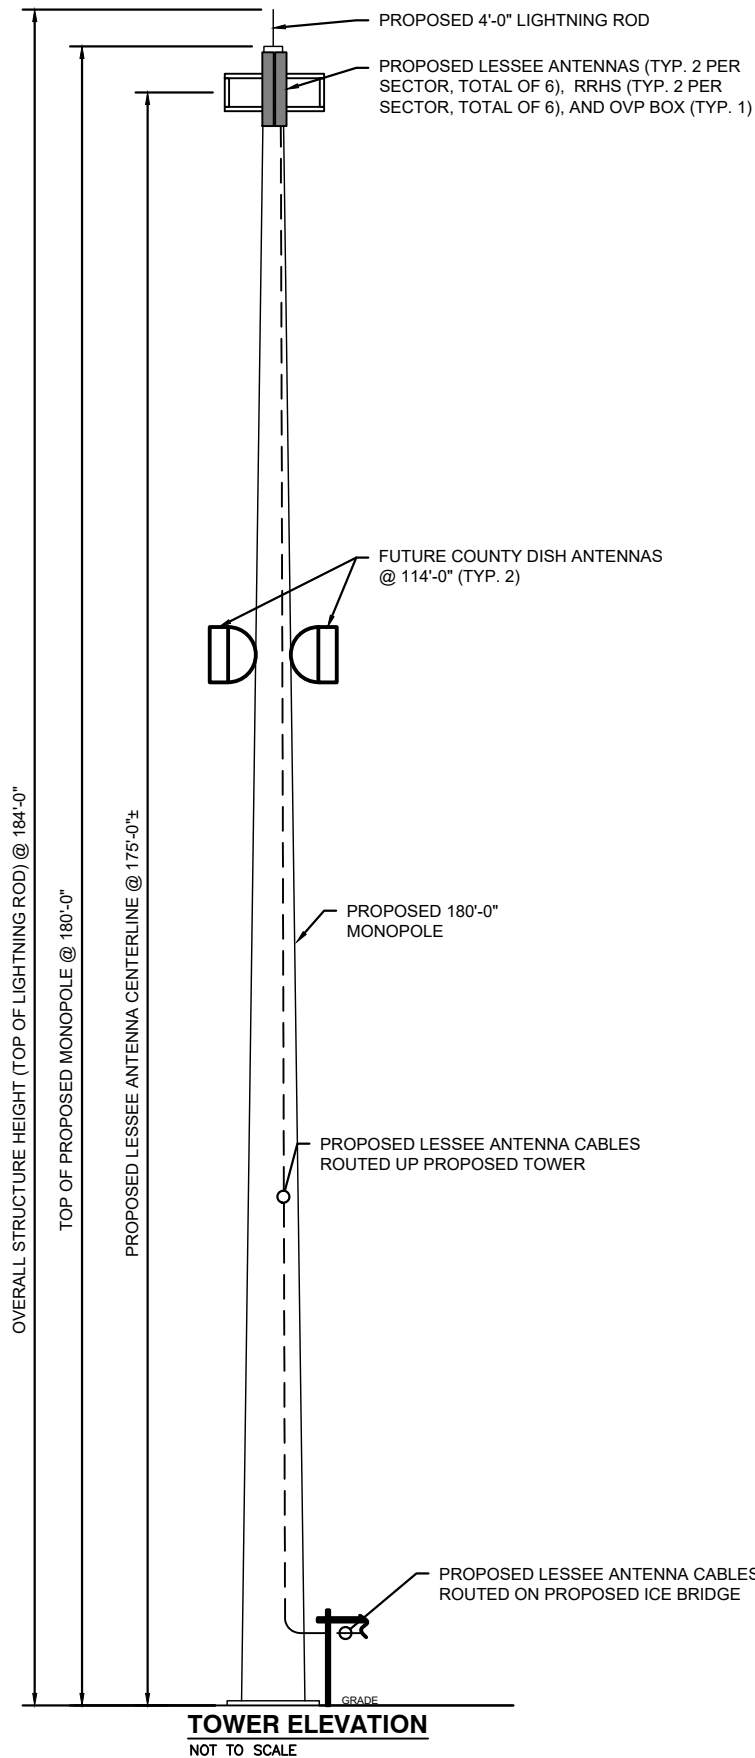

TOWER ELEVATION
 NOT TO SCALE



C&S Engineers, Inc.
 499 Col. Eileen Collins Blvd.
 Syracuse, New York 13212
 Phone: 315-455-2000
 Fax: 315-455-9667
 www.cscos.com

SITE NAME: AURIESVILLE
PROJECT NUMBER: 2014107930
LOCATION CODE: 298618

200 CLARK DRIVE
 FULTONVILLE, NY 12072

ORIGINAL DATE: 12-9-20 REVISION DATE: 1-8-21



TOWER ELEVATION

DRAWING NUMBER	REV
C-201	1